

MODEL MARKET 2



CLIENT:


**MINISTRY OF LOCAL GOVERNMENT ,
CHIEFTAINCY & RELIGIOUS AFFAIRS**

PROJECT:

**PROPOSED 24-HOUR ECONOMY MARKET
&
COMMERCIAL CENTRE**



LOCATION :

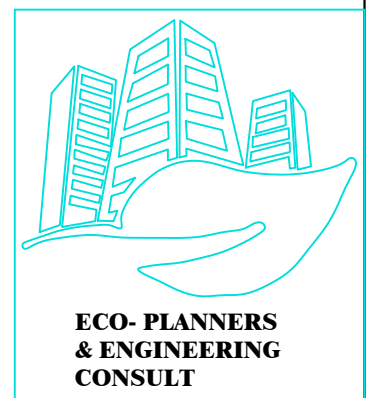

BLOCK F

LIVESTOCK BAY


PROPOSED 24-HOUR ECONOMY MARKET & COMMERCIAL CENTRE — MODEL MARKET 2

DRAWING SCHEDULE

Client: Ministry of Local Government,
Chieftaincy & Religious Affairs

Eco-Planners & Engineering Consult

SHEET	DISCIPLINE	DRAWING TITLE	PAGE IN ORIGINAL SET
ARCHITECTURAL DRAWINGS			
1	Architectural	Architectural Drawings — Section Cover	p. 2
2	Architectural	Block F — Livestock Bay (Section Cover)	p. 61
3	Architectural	3D Impression — Block F	p. 62
4	Architectural	Ground Floor Plan	p. 63
5	Architectural	Elevations — Front & Left Side	p. 64
6	Architectural	Elevations — Back & Right Side	p. 65
7	Architectural	Sections	p. 66
8	Architectural	Roof Plan	p. 67
9	Architectural	Door / Window Schedule	p. 68
10	Architectural	Finishes Schedule	p. 69
SERVICES DRAWINGS			
11	Services	Electrical, Fire System, AC & Plumbing Drawings — Section Cover	p. 108
12	Services	Block F (Section Cover)	p. 165
13	Services	Electrical Layout (Lighting System)	p. 166
14	Services	Electrical Circuit Control Unit — Schematic	p. 167

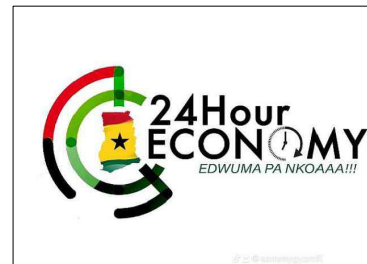

ARCHITECTURAL DRAWINGS


- 3D IMPRESSIONS
- MARKET GENERAL LAYOUTS
- UNIT FLOOR PLANS
- SECTIONS
- ELEVATIONS



BLOCK F

LIVESTOCK BAY



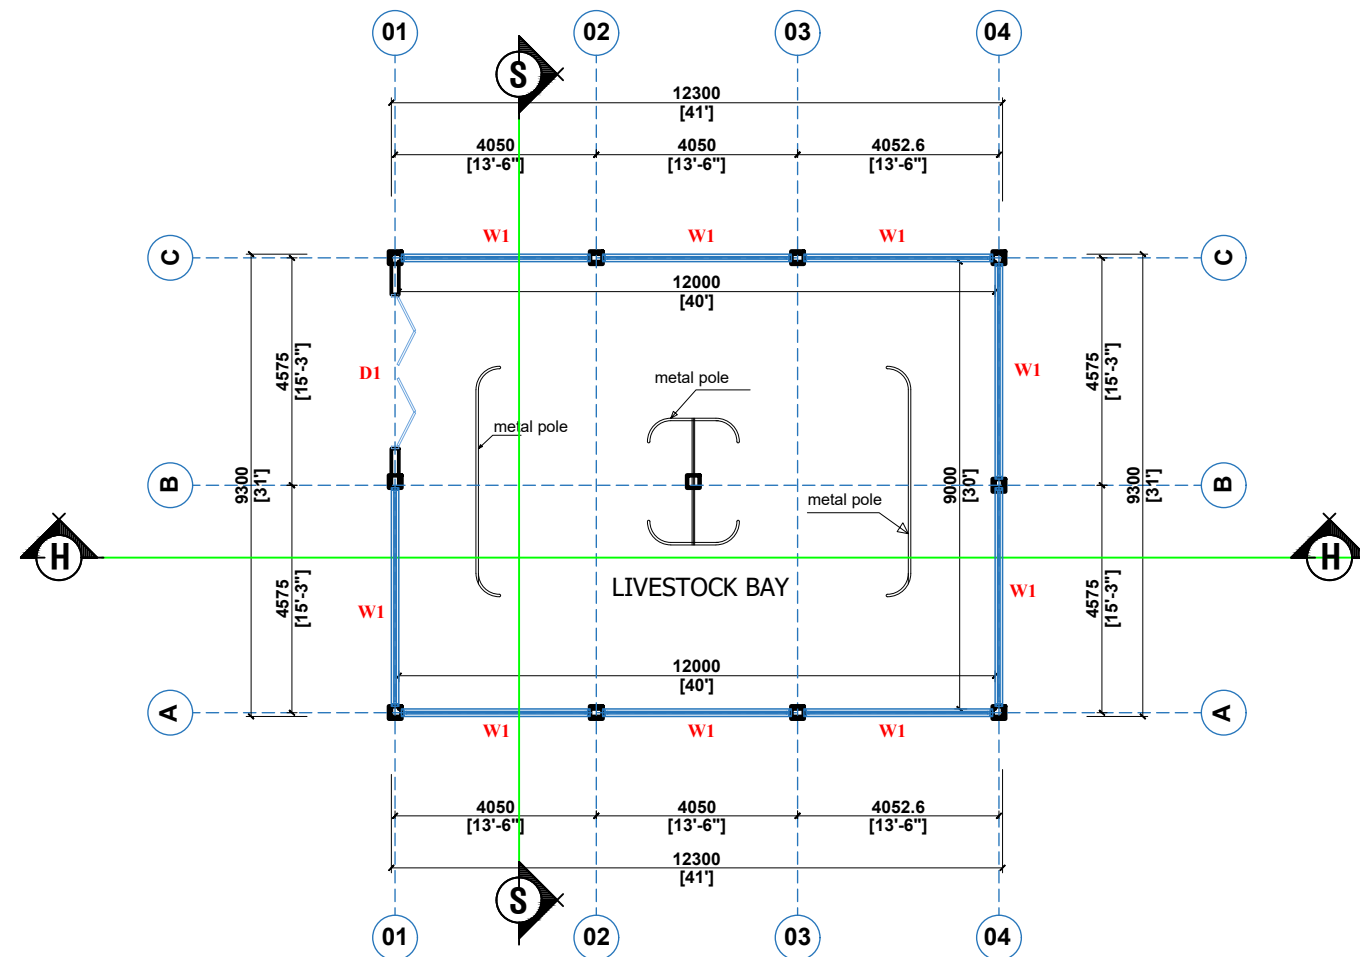

CLIENT:

DRAWING TITLE:

DATE:

MINISTRY OF LOCAL GOVERNMENT ,
CHIEFTAINCY & RELIGIOUS AFFAIRS

GROUND FLOOR PLAN

OCTOBER, 2025

PROJECT : **PROPOSED 24-HOUR
ECONOMY MARKET
&
COMMERCIAL CENTRE**



NOTE : - DIRECT MEASUREMENT IS NOT ALLOWED
- FOR ANY CLARIFICATION CONTACT (" +233 247 898" 540 OR
" +233 242 316 175" or " +233 271 010 146") ECO PLANNERS &
ENGINEERING CONSULT

SCALE:

DESIGNED BY:

DRAWN BY:


1 : 100

**ECO - PLANNERS &
ENGINEERING CONSULT**


C. O. ABOARH & A. FRANK

DRG NO.:


A01

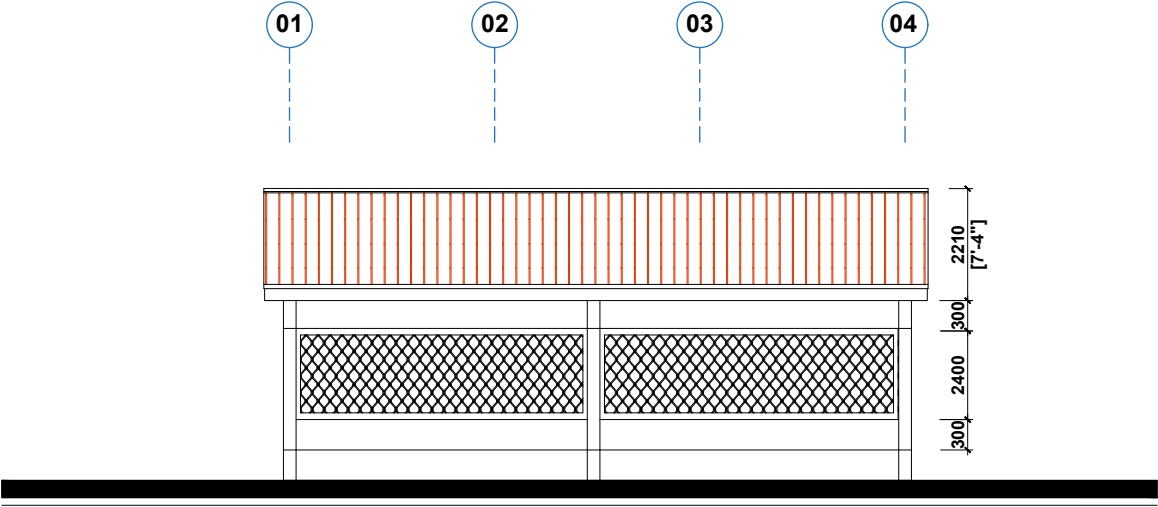

FRONT ELEVATION

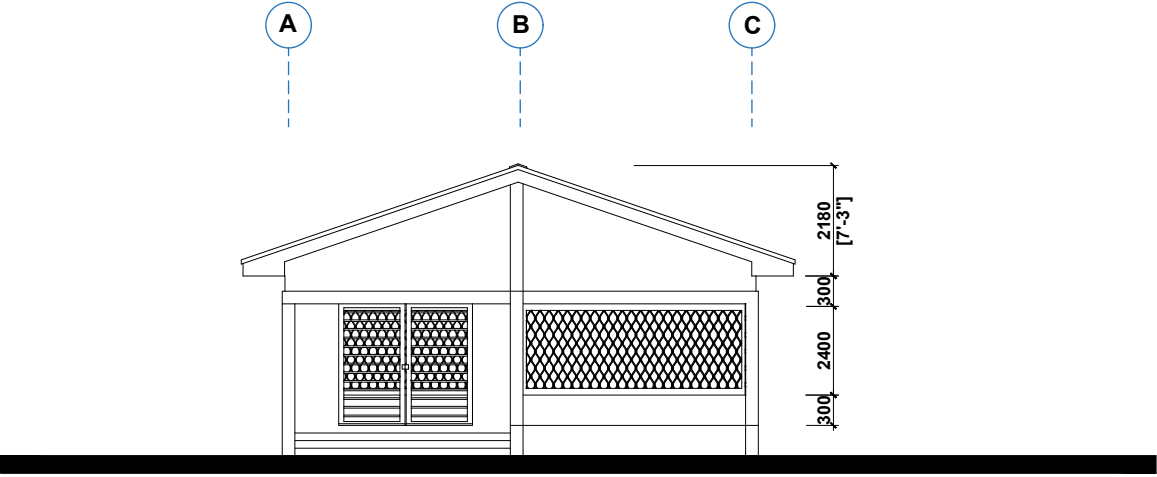

LEFT SIDE ELEVATION

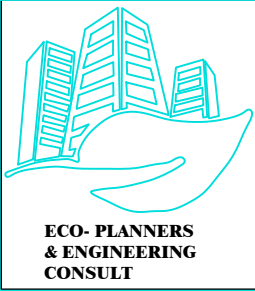

CLIENT:

MINISTRY OF LOCAL GOVERNMENT ,
CHIEFTAINCY & RELIGIOUS AFFAIRS

DRAWING
TITLE:

ELEVATIONS

DATE:

OCTOBER, 2025

PROJECT : **PROPOSED 24-HOUR
ECONOMY MARKET
&
COMMERCIAL CENTRE**



NOTE : - DIRECT MEASUREMENT IS NOT ALLOWED
- FOR ANY CLARIFICATION CONTACT (" +233 247 898" 540 OR
"+233 242 316 175" or "+233 271 010 146") ECO PLANNERS &
ENGINEERING CONSULT

SCALE:

1 : 100

DESIGNED BY:


**ECO - PLANNERS &
ENGINEERING CONSULT**

DRAWN BY:


C. O. ABOARH & A. FRANK

DRG NO.:

A02

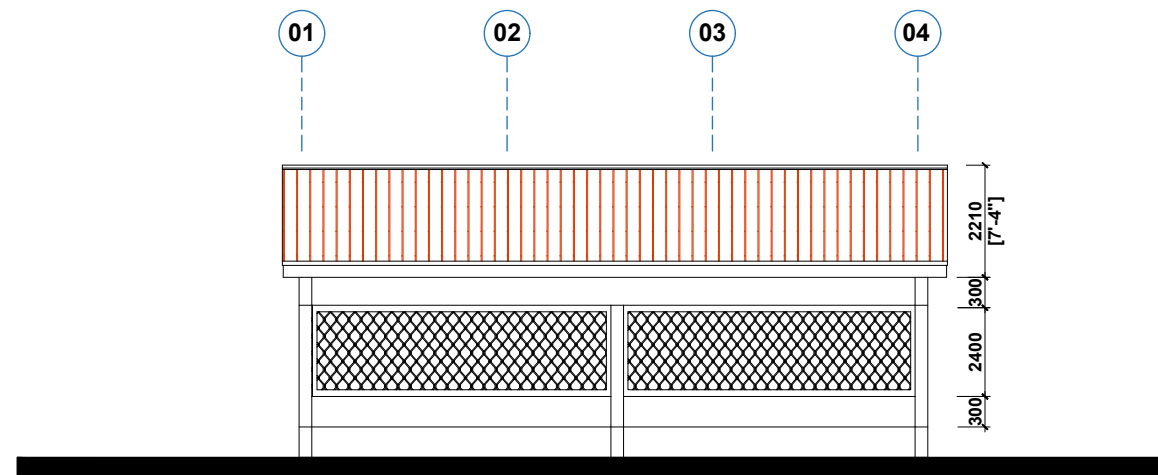



BACK ELEVATION

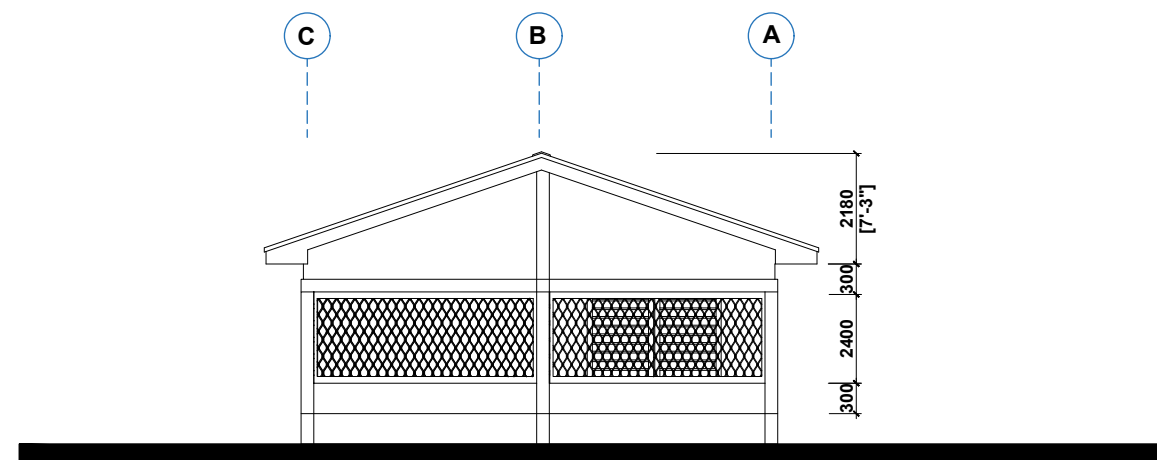


RIGHT SIDE ELEVATION

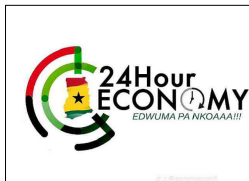


CLIENT:	MINISTRY OF LOCAL GOVERNMENT , CHIEFTAINCY & RELIGIOUS AFFAIRS	PROJECT : PROPOSED 24-HOUR ECONOMY MARKET & COMMERCIAL CENTRE 	SCALE:	1 : 100	DRG NO.: A03
DRAWING TITLE:	ELEVATIONS		DESIGNED BY:	ECO - PLANNERS & ENGINEERING CONSULT	
DATE:	OCTOBER, 2025		NOTE : - DIRECT MEASUREMENT IS NOT ALLOWED - FOR ANY CLARIFICATION CONTACT (" +233 247 898" 540 OR " +233 242 316 175" or " +233 271 010 146") ECO PLANNERS & ENGINEERING CONSULT	DRAWN BY:	

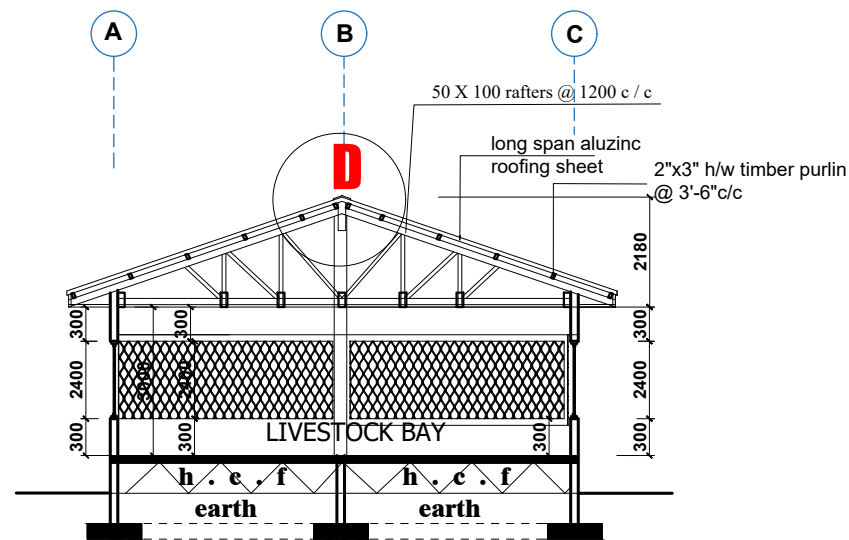


SECTION S - S
SCALE : 1 : 100

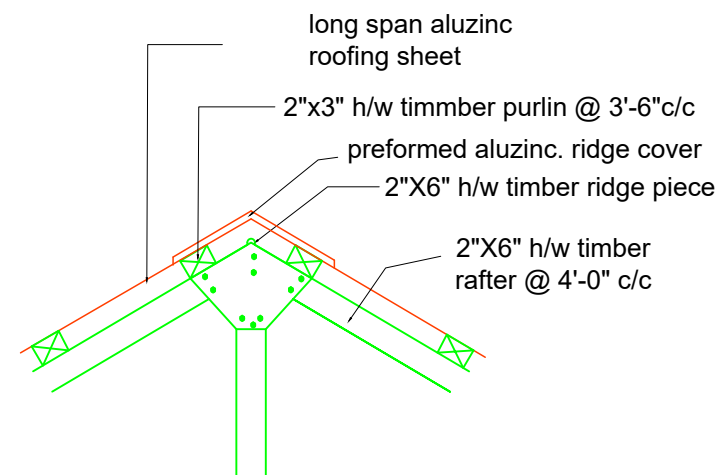

DETAIL "D"

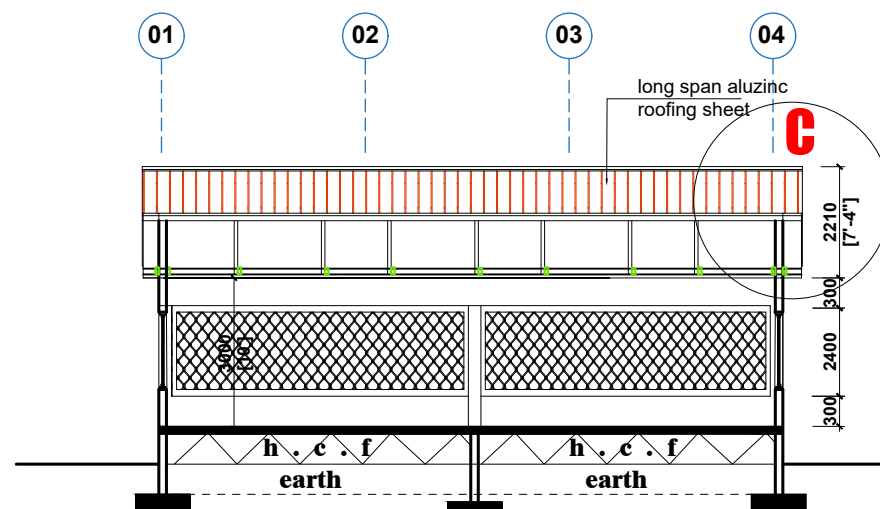


SECTION H - H
SCALE : 1 : 100

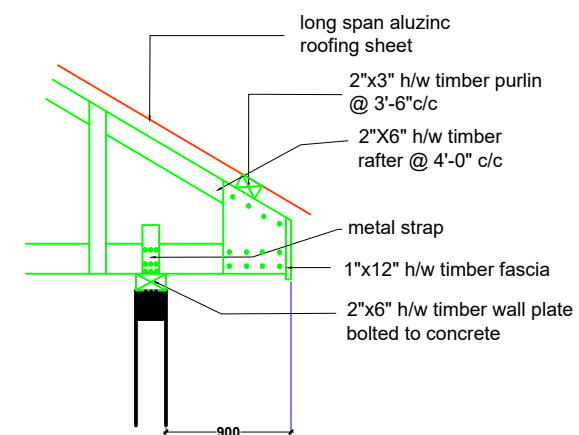

DETAIL "C"




CLIENT: DRAWING TITLE: DATE:	MINISTRY OF LOCAL GOVERNMENT , CHIEFTAINCY & RELIGIOUS AFFAIRS	PROJECT : PROPOSED 24-HOUR ECONOMY MARKET & COMMERCIAL CENTRE NOTE : - DIRECT MEASUREMENT IS NOT ALLOWED FOR ANY CLARIFICATION CONTACT (" +233 247 898" 540 OR "+233 242 316 175" or "+233 271 010 146") ECO PLANNERS & ENGINEERING CONSULT		SCALE:	1 : 100	DRG NO.: A04
	SECTIONS			DESIGNED BY:	ECO - PLANNERS & ENGINEERING CONSULT	
	OCTOBER, 2025			DRAWN BY:	C. O. ABOARH & A. FRANK	

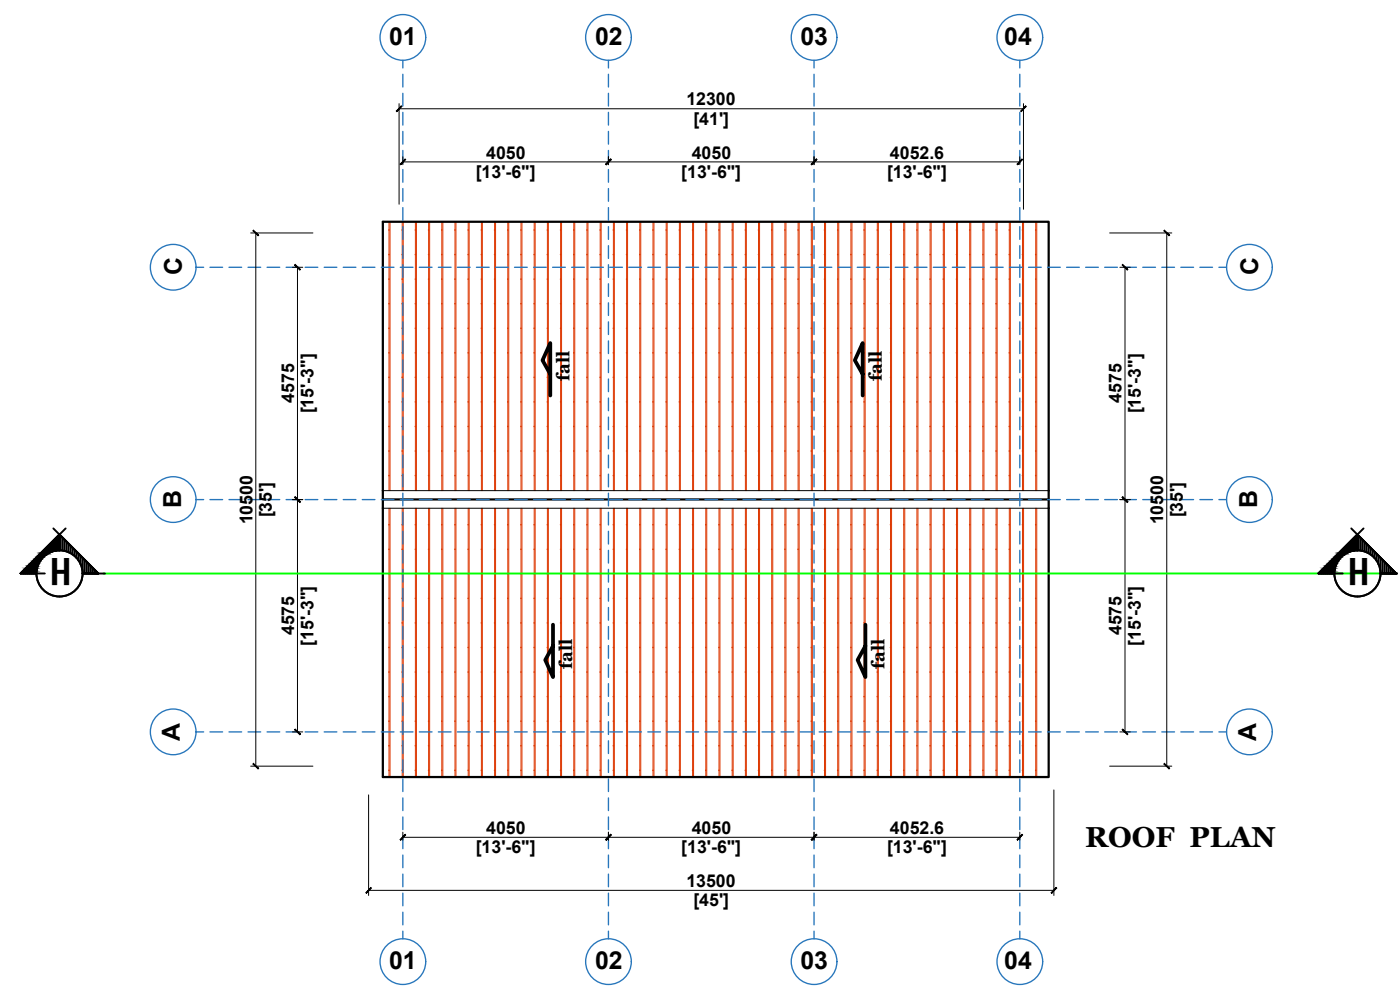

CLIENT:	MINISTRY OF LOCAL GOVERNMENT , CHIEFTAINCY & RELIGIOUS AFFAIRS	PROJECT : PROPOSED 24-HOUR ECONOMY MARKET & COMMERCIAL CENTRE  NOTE : - DIRECT MEASUREMENT IS NOT ALLOWED FOR ANY CLARIFICATION CONTACT (" +233 247 898" 540 OR "+233 242 316 175" or "+233 271 010 146") ECO PLANNERS & ENGINEERING CONSULT	SCALE:	1 : 100	DRG NO.: A05
DRAWING TITLE:	ROOF PLAN		DESIGNED BY:	ECO - PLANNERS & ENGINEERING CONSULT	
DATE:	OCTOBER, 2025		DRAWN BY:	C. O. ABOARH & A. FRANK	

WINDOWS SKETCH


W1

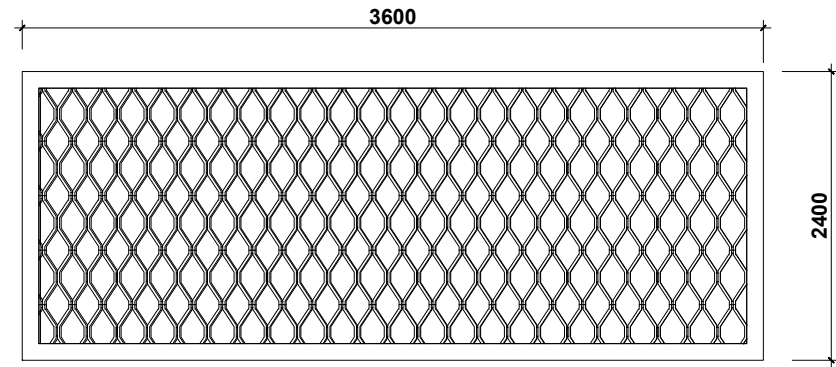


MODEL TAG :	W1
DESCRIPTION :	LOUVRED WINDOW FINISH WITH APPROVED OIL PAINT AS PER SPECIFICATION
QUANTITY :	9no.
FINISHES :	PRE-COATED FRAMES
LOCATION :	AS INDICATED ON PLAN

DOORS SKETCH

D1

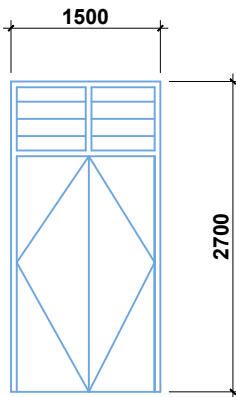

MODEL TAG :	D1
DESCRIPTION :	TIMBER- FRAMED, HINGED PANEL DOOR WITH FANLIGHT
QUANTITY :	1no.
FINISHES :	POLISHED DOOR / DARK BROWN IN COLOUR
LOCATION :	AS INDICATED ON PLAN

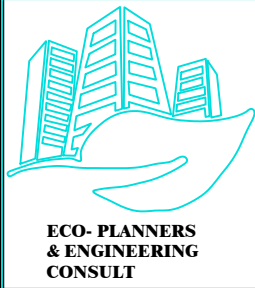

CLIENT:

MINISTRY OF LOCAL GOVERNMENT ,
CHIEFTAINCY & RELIGIOUS AFFAIRS

DRAWING
TITLE:

DOOR / WINDOW SCHEDULE

DATE:

OCTOBER, 2025

PROJECT : **PROPOSED 24-HOUR
ECONOMY MARKET
&
COMMERCIAL CENTRE**



NOTE : - DIRECT MEASUREMENT IS NOT ALLOWED
- FOR ANY CLARIFICATION CONTACT (" +233 247 898" 540 OR
" +233 242 316 175" or " +233 271 010 146") ECO PLANNERS &
ENGINEERING CONSULT

SCALE:

1 : 100

DESIGNED BY:

**ECO - PLANNERS &
ENGINEERING CONSULT**

DRAWN BY:

C. O. ABOARH & A. FRANK

DRG NO.:

A06

FINISHES SCHEDULE

LEGEND

FULL BODY FLAMED & LAPPED FLOOR TILE - FFL, FL
CERAMIC FLOOR TILE - CFT

SMALL FLOOR TILE	-	RFT
CERAMIC WALL TILE	-	CWT
PLASTER OF PARIS	-	POP
3MM WOODEN PLYWOOD	-	WP
		PT&G
CAROL EMULSION PAINT	-	CEP
CORAL OIL PAINT	-	COP
GREEN HEDGES AND GRASS	-	GHG
QUARRY CHIPPINGS	-	QC
NOT APPLICABLE	-	N/A

DESCRIPTION	
	Floor, wall and Ceiling as per specification

ROOM #	ROOM NAME	FLOOR	WALLS	CEILING
--------	-----------	-------	-------	---------

[illegible]

CLIENT:

**DRAWING
TITLE:**

DATE:

**MINISTRY OF LOCAL GOVERNMENT ,
CHIEFTAINCY & RELIGIOUS AFFAIRS**

FINISHES SCHEDULE

OCTOBER, 2025

PROJECT :

PROPOSED 24-HOUR
ECONOMY MARKET
&
COMMERCIAL CENTRE



SCALE:

DESIGNED BY:

DRAWN BY:

1 : 100

**ECO - PLANNERS &
ENGINEERING CONSULT**


C. O. ABOARH & A. FRANK

DRG NO.:


A07

ELECTRICAL, FIRE SYSTEM, AC & PLUMBING DRAWINGS

BLOCK F

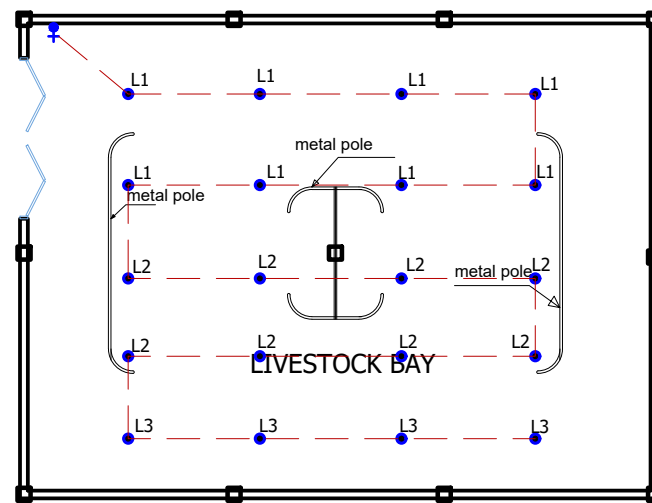

 ECO- PLANNERS & ENGINEERING CONSULT	CLIENT:	MINISTRY OF LOCAL GOVERNMENT , CHIEFTAINCY & RELIGIOUS AFFAIRS	PROJECT : PROPOSED 24-HOUR ECONOMY MARKET & COMMERCIAL CENTRE		SCALE:	1 : 100	DRG NO.: E01
	DRAWING TITLE:	ELECTRICAL LAYOUT (LIGHTING SYSTEM)			DESIGNED BY:	ECO - PLANNERS & ENGINEERING CONSULT	
	DATE:	OCTOBER, 2025	NOTE : - DIRECT MEASUREMENT IS NOT ALLOWED - FOR ANY CLARIFICATION CONTACT (" +233 247 898" 540 OR " +233 242 316 175" or " +233 271 010 146") ECO PLANNERS & ENGINEERING CONSULT		DRAWN BY:	C. O. ABOARH & A. FRANK	

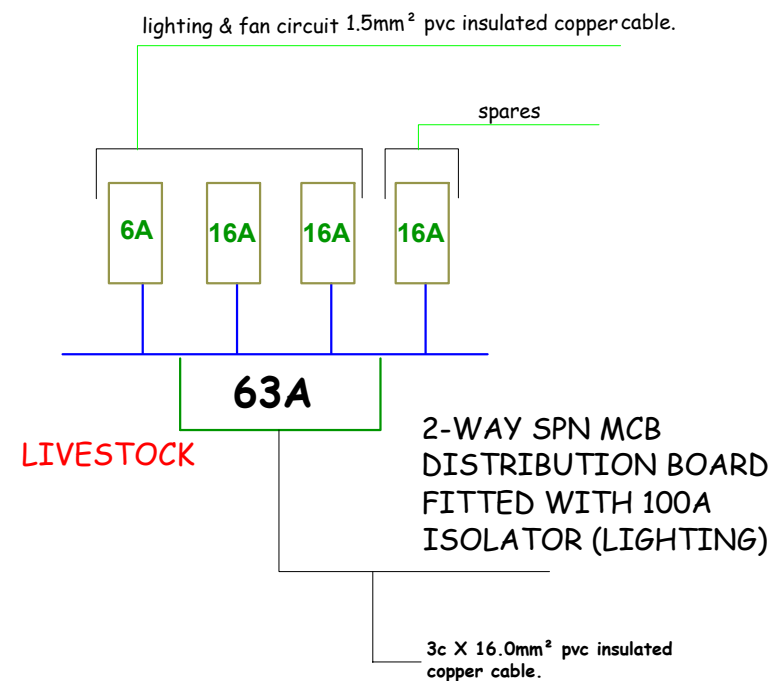

LEGEND

(POWER LOAD FOR GF & FF)

A	TOTAL ASSUMED LIGHTING LOAD(KW)						0.2536
	2 x 13A switch socket outlet.	3	0.600	1.8	0.6	1.08	
	32A DP air condition switch	1	2.700	2.7	0.8	2.16	
	20-litre capacity water heater.	0	1.200	0	0.8	0	
B	TOTAL ASSUMED POWER LOAD(KW)						3.24
	TOTAL ASSUMED LOAD(KW) A+B						3.5

 ECO- PLANNERS & ENGINEERING CONSULT	CLIENT:	MINISTRY OF LOCAL GOVERNMENT , CHIEFTAINCY & RELIGIOUS AFFAIRS	PROJECT : PROPOSED 24-HOUR ECONOMY MARKET & COMMERCIAL CENTRE 	SCALE:	1 : 100	DRG NO.: E02
	DRAWING TITLE:	ELECTRICAL CIRCUIT CONTROL UNIT		DESIGNED BY:	ECO - PLANNERS & ENGINEERING CONSULT	
	DATE:	OCTOBER, 2025		DRAWN BY:	C. O. ABOARH & A. FRANK	
			NOTE : - DIRECT MEASUREMENT IS NOT ALLOWED FOR ANY CLARIFICATION CONTACT (" +233 247 898" 540 OR "+233 242 316 175" or "+233 271 010 146") ECO PLANNERS & ENGINEERING CONSULT			